

Revisions		
No.	Description	Date

Approval Stamp:



Taco Bell  
 Endeavor Medium 40

Mainland Pointe  
 Main Street & Quarry Road  
 Harleysville, Pennsylvania  
 19438

Equipment and Seating Plan  
 - First Floor

Project No. W02920
Date: 07/03/2020
Drawn By: SM
Scale: As Noted
PA License No. 000102

EQUIPMENT & SEATING PLAN - FIRST FLOOR 1/8" = 1'-0" A

QTY	NAME	FAMILY	FRAME OR MURAL	SIZE	LOCATION
1	HYPNOTIZE ME BELL	D	M01	17'7"X6'7"	SEE AB.0
1	CAMO PATTERN	D	F01	28x40	SEE AB.0
1	CAMO PATTERN	D	F02	28x40	SEE AB.0
1	CAMO PATTERN	D	F01	28x40	SEE AB.0

ARTWORK SCHEDULE 3/8" = 1'-0" E

TAG	QTY	ITEM DESCRIPTION
D-700	7	22" X 22" X 28.5" H FREE STANDING TABLE BASE
D-703	6	22" X 5.5" X 28.5" H FREE STANDING TABLE BASE
T-201a	6	BARREL BARSTOOL - 29 PURPLE WOOD SEAT
T-3000a	2	BENCH BACK REST - 48"
T-302a	2	BENCH SEAT - 48"
T-3030a	1	BENCH BACK REST - 60"
T-303a	1	BENCH SEAT - 60"
T-401a	1	HUB TABLE - 72" - HIGH TOP
T-402a	1	HUB TABLE - 48" - HIGH TOP
T-405a	5	LAMINATE TABLE - 24 X 20 X 30 - 2 TOP
T-408a	3	LAMINATE TABLE ADA - 24 X 48 X 30 - 4 TOP
T-411a	2	SS TABLE - 24 DIA X 30 - 2 TOP
T-506a	1	COUNTER TOP - 48" X 20" X 30"
T-506a	1	COUNTER TOP - 60" X 20" X 30"
T-613a	1	POS COUNTER 121 - 2 POS - 17'-0" X 2'-0"

SEATING PACKAGE - SEATING VENDOR U.O.N. D

TAG	QTY	ITEM DESCRIPTION
T-620a	1	CONDIMENT COUNTER - RECTANGLE
T-706a	1	WASTE ENCLOSURE - SINGLE
T-708a	1	WASTE ENCLOSURE - 3 STREAM
T-901a	29	CHAIR - LAMINATE SEAT

- GOODS**
- REFER TO SC SHEETS FOR SCOPE OF WORK RESPONSIBILITIES.
  - (H) SYMBOL DENOTES A HIGH TABLE OR DRINK COUNTER WITH STOOLS.
  - (HC) SYMBOL DENOTES A HANDICAP ACCESSIBLE TABLE.
  - (FD) SYMBOL DENOTES FIRE EXTINGUISHER LOCATION.

GENERAL NOTES C1

SQUARE FOOTAGE		SEATING	
FOH	860 SF	INTERIOR DINING	40
BOH	1,070 SF	EXTERIOR	-
TOTAL	2,087 SF	TOTAL	40


SHELVING QUANTITIES		
STORAGE TYPE	REQUIRED	PROVIDED
DRY	36LF	48LF
COLD	0LF	26LF
FROZEN	0LF	10LF

GENERAL INFORMATION C

- (E21) ELECTRICAL PANELS
- (E22) HOOD FIRE SUPPRESSION SYSTEM (ANSI, R-102 OR EQUAL)
- (E23) MAINTAIN 36" MINIMUM CLEAR ACCESSIBLE AGILE EGRESS PATHS TO EXIT DOORS, 3" AT CORNERS AND GATE OPENINGS. (42" AGILE REQUIRED WHEN ABLE SERVES MORE THAN 50 SEATS)
- (E24) ALERT LIGHT BOX FOR 3-COMPARTMENT POWER SOAK
- (E25) PULL STATION @ 3'-8" A.F.F.
- (E26) COORDINATE LOCATION OF HORIZONTAL PVC 5/8" VRLP CHASE THRU WALL TO COUNTER
- (E27) ROOF LADDER WITH BILCO LADDER UP SAFETY POST
- (E28) SPLASH GUARD
- (E29) AUTOMATIC HAND SOAP AND SANITIZER DISPENSERS PROVIDED BY ECOLAB

KEY NOTES B

A2.0

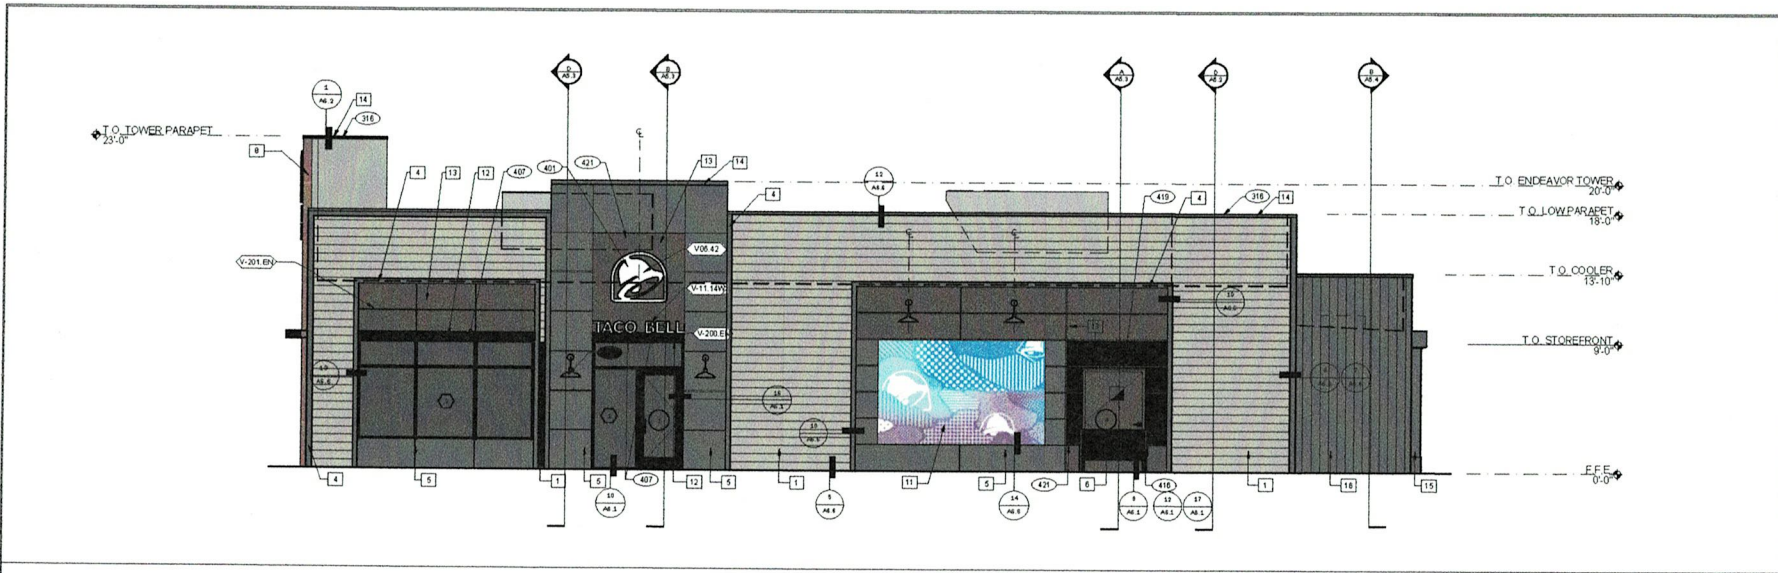

**EAST ELEVATION 1/4" = 1'-0" A**

Revisions		
No.	Description	Date

Approval Stamp:

TYPE MARK	QTY	ITEM DESCRIPTION	LOC
TOWER			
V-04 42	2	LARGE 42" SWINGING BELL LOGO - FACE LIT - 3' 0" X 3' 10 3/8"	AA.1
V-00 14W	2	LARGE TB 14" WHITE CHANNEL LETTERS - STACKED - WALL MOUNTED	AA.1
FRONT ENTRY			
V-06 42	1	42" SWINGING BELL WHITE LOGO - FACE LIT - 3' 0" X 3' 10 3/8"	AA.0
V-11 14W	1	14" WHITE CHANNEL LETTERS - LINEAR - AWNINGS MOUNTED	AA.0
V-200 EN	1	SIDE ENTRY AWNING 6' 4" X 6' 3" BLACK	AA.0
DRIVE THRU			
V-101 DT	1	DT AWNING (OVER DT) 9' 6" X 4' 10" BLACK	AA.1
EYEBROW AWNINGS			
V-202 EN	1	FRONT EYEBROW (WINDOW) 16' 7" X 6" H X 1' 4" D BLACK	AA.1
V-203 EN	1	DT EYEBROW (WINDOW) 7' 8" L X 6" H X 1' 4" D BLACK	AA.1
V-201 EN	1	SIDE ENTRY EYEBROW (WINDOW) 12' L X 6" H X 1' 4" D BLACK	AA.0

**SIGNAGE E**

- (14) METAL PARAPET CAP
- (21) BUILDING SIGN BY VENDOR. REQUIRES ELECTRICAL, SEE ELECTRICAL PLANS.
- (40) METAL CANOPIES BY SIGNAGE VENDOR. SEE SCHEDULE FOR FINISH.
- (41) CO2 FILLER VALVE & COVER.
- (43) HOSE BIB BOX AT 18" A.F.F.
- (45) EXTERIOR LIGHT FIXTURE. COORDINATE WITH ELECTRICAL DRAWINGS.
- (46) MURAL.

**KEY NOTES E**

SYMBOL	ITEM/MATERIAL	MANUFACTURER	MATERIAL SPEC	COLOR	CONTACT INFORMATION
1	SIGNING	JAMES HARDE	ARTISAN V-GROOVE RUSTIC 144" X 8.25" W, 7" EXPOSURE COMES PRIMED FOR PAINT	WORLDLY GRAY (SW7043), SEMI-GLOSS	SEE D/A.7.2
2	SCULPTORS	-	-	WORLDLY GRAY (SW7043), SEMI-GLOSS	SEE D/A.7.2
3	DOWN SPOUTS	-	-	WORLDLY GRAY (SW7043), SEMI-GLOSS	SEE D/A.7.2
4	HARDE TRIM	JAMES HARDE	HARDE TRIM 5/4 SMOOTH 1.5" X 5"	CYBERSPACE (SW7076), SEMI-GLOSS	SEE D/A.7.2
5	HARDE REVEAL PANEL	JAMES HARDE	REVEAL PANEL SYSTEM	CYBERSPACE (SW7076), SEMI-GLOSS	SEE D/A.7.2
6	HOLLOW METAL DOOR	-	-	PURPLE TB2603C & FRAME, SEMI-GLOSS	SEE D/A.7.2
7	AWNINGS	-	-	CYBERSPACE (SW7076), SEMI-GLOSS	SEE D/A.7.2
8	CORNER TOWER	-	-	WEATHERED RUSTIC - WESTERN STATES	SEE D/A.7.2
9	RECESS OF SIDE ENTRY PORTAL	-	-	PURPLE (ST2603C)	SEE D/A.7.2
10	EXTERIOR ARTWORK PANELS (OPTIONAL)	JAMES HARDE	REVEAL PANEL SYSTEM	PURPLE STB2603C RUSTIC	SEE D/A.7.2
11	EXTERIOR MURAL	-	-	-	SEE D/A.7.2
12	METAL CANOPIES	SIGNAGE VENDOR	-	-	SEE D/A.7.2
13	HARDE REVEAL PANEL	JAMES HARDE	REVEAL PANEL SYSTEM	PURPLE (SW7B2603C)	SEE D/A.7.2
14	METAL PARAPET CAP	-	-	CYBERSPACE (SW7076)	SEE D/A.7.2
15	DOWN SPOUTS	-	-	CYBERSPACE (SW7076), SEMI-GLOSS	SEE D/A.7.2
16	SIGNING	JAMES HARDE	ARTISAN V-GROOVE RUSTIC 144" X 8.25" W, 7" EXPOSURE COMES PRIMED FOR PAINT	CYBERSPACE (SW7076), SEMI-GLOSS	SEE D/A.7.2

**EXTERIOR FINISH SCHEDULE B**

- MISCELLANEOUS**
- A. SEE SHEET A.1 "WINDOW TYPES" FOR WINDOW ELEVATIONS.
- SEALERS (REFER TO SPEC)**
- A. SEALANT AT ALL WALL AND ROOF PENETRATIONS.
  - B. SEALANT AT ALL WINDOW AND DOOR FRAMES AND JAMB. DO NOT SEAL SILL @ WINDOWS.
  - C. APPLY NEOPRENE GASKET (CONT.) BETWEEN BUILDING AND CANOPY.

NOTE: NO EXTERIOR SIGNS ARE WITHIN THE SCOPE OF WORK COVERED BY THE BUILDING PERMIT APPLICATION. THE GENERAL CONTRACTOR SHALL BE RESPONSIBLE FOR COORDINATING THE INSTALLATION OF ALL EXTERIOR SIGNS AND INSTALLATION OF REQUIRED BLOCKING AND ELECTRICAL CONNECTIONS FOR FINAL APPROVED SIGNS.

**PAINTING**

APPLICATOR MUST DO THEIR DUE DILIGENCE WITH PREPARATION.

PRIMER: 1 COAT SWA24MB200

FINISH: 2 COATS SWA82-100 SERIES, MATCH COLORS FROM MATERIAL SCHEDULE

A-100 EXTERIOR LATEX SATIN

**GENERAL NOTES D**

**PAINT NOTES C**


Taco Bell  
 Endeavor Medium 40  
 Mainland Pointe  
 Main Street & Quarry Road  
 Harleysville, Pennsylvania  
 19438

**Exterior Elevations**


Project No. W02-920
Date: 07/01/2020
Drawn By: SM
Scale: As Noted
PA License No. 02062

**A4.0**




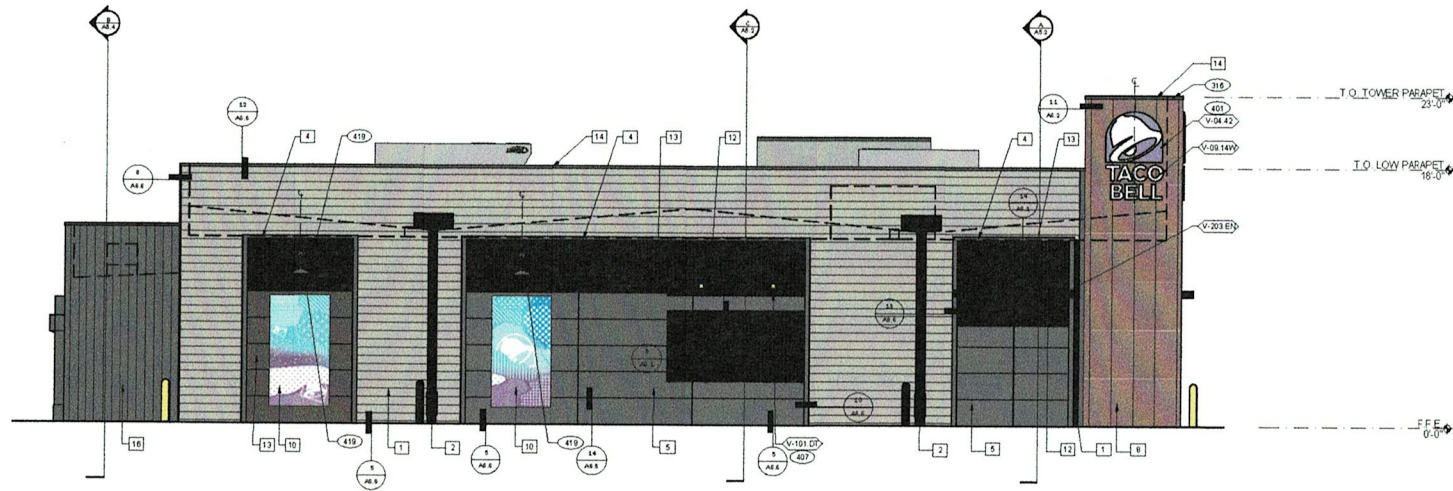

WEST ELEVATION 1/8" = 1'-0" A

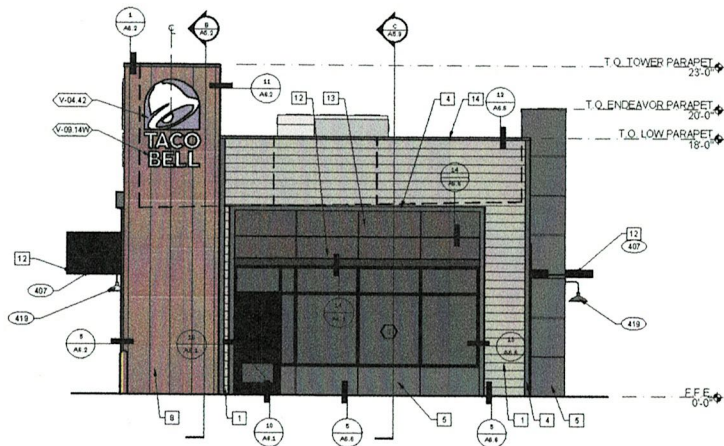

SOUTH ELEVATION 1/8" = 1'-0" C

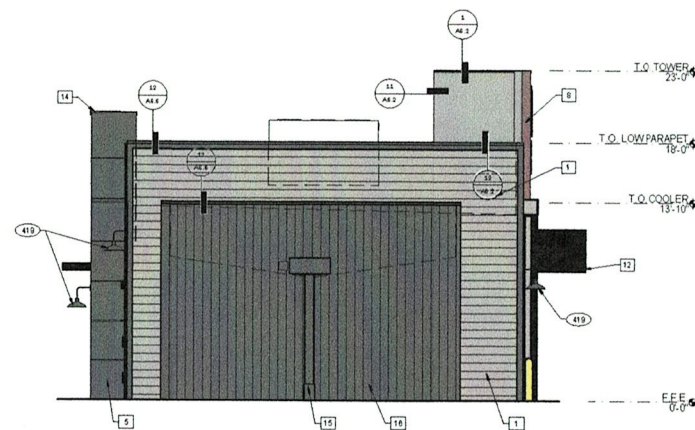

NORTH ELEVATION 1/8" = 1'-0" B

- (114) METAL PARAPET CAP.
- (407) BUILDING SIGN BY VENDOR. REQUIRES ELECTRICAL, SEE ELECTRICAL PLANS.
- (407) METAL CANOPIES BY SIGNAGE VENDOR. SEE SCHEDULE FOR FINISH.
- (408) CO2 FILLER VALVE & COVER.
- (419) HOSE RIB BOX AT 18" A.F.F.
- (411) EXTERIOR LIGHT FIXTURE. COORDINATE WITH ELECTRICAL DRAWINGS.
- (412) MURAL.

NOTE: REFERENCE TO SHEET A4.0 FOR COLOR LEGEND

NOT USED E

KEY NOTES D

Revisions		
No.	Description	Date

Approval Stamp:



Taco Bell  
 Endeavor Medium 40  
 Mainland Pointe  
 Main Street & Quarry Road  
 Harleysville, Pennsylvania  
 19438

Exterior Elevations

Project No. W02-20-20
Date: 07/01/2020
Drawn By: SM
Scale: As Noted
PA License No. 00282

A4.1